


## EXTERIOR LIGHTING FIXTURE SCHEDULE

TYPE	LAMP	WATTS	DESCRIPTION	CATALOG NO.
Y1	LED	166	LED POLE MOUNTED FIXTURE WITH TYPE IV DISTRIBUTION & DARK BRONZE FINISH. MOUNTED ON A 20' TALL SQUARE STRAIGHT STEEL POLE.	LITHONIA# KAX1-LED-P4-50K-R4-MVOLT-SPA-DBXD POLE - LITHONIA# SSS-20'-5G-DM19AS-DBXD
Y2	LED	166	LED POLE MOUNTED FIXTURE WITH TYPE IV DISTRIBUTION. FULL CUTOFF HOUSE SIDE SHIELD & DARK BRONZE FINISH. MOUNTED ON A 20' TALL SQUARE STRAIGHT STEEL POLE.	LITHONIA# KAX1-LED-P4-50K-R4-MVOLT-SPA-DBXD POLE - LITHONIA# SSS-20'-5G-DM19AS-DBXD
Y3	LED	320	(2)LED POLE MOUNTED FIXTURE WITH TYPE 5 DISTRIBUTION MOUNTED AT 180 DEGREES & DARK BRONZE FINISH. MOUNTED ON A 20' TALL SQUARE STRAIGHT STEEL POLE.	LITHONIA# (2)KAX1-LED-P4-50K-R5-MVOLT-SPA-DBXD POLE - LITHONIA# SSS-20'-5G-DM28AS-DBXD
Y4	LED	160	LED POLE MOUNTED FIXTURE WITH TYPE 3 DISTRIBUTION. FULL CUTOFF HOUSE SIDE SHIELD & DARK BRONZE FINISH. MOUNTED ON A 20' TALL SQUARE STRAIGHT STEEL POLE.	LITHONIA# KAX1-LED-P4-50K-R3-MVOLT-SPA-DBXD POLE - LITHONIA# SSS-20'-5G-DM19AS-DBXD

### STATISTICS

(VALUES ARE MAINTAINED)


Description	Avg	Max	Min	Max/Min	Avg/Min
PARKING FIELD	3.9 fc	10.2 fc	0.2 fc	51:0.1	19:5.1

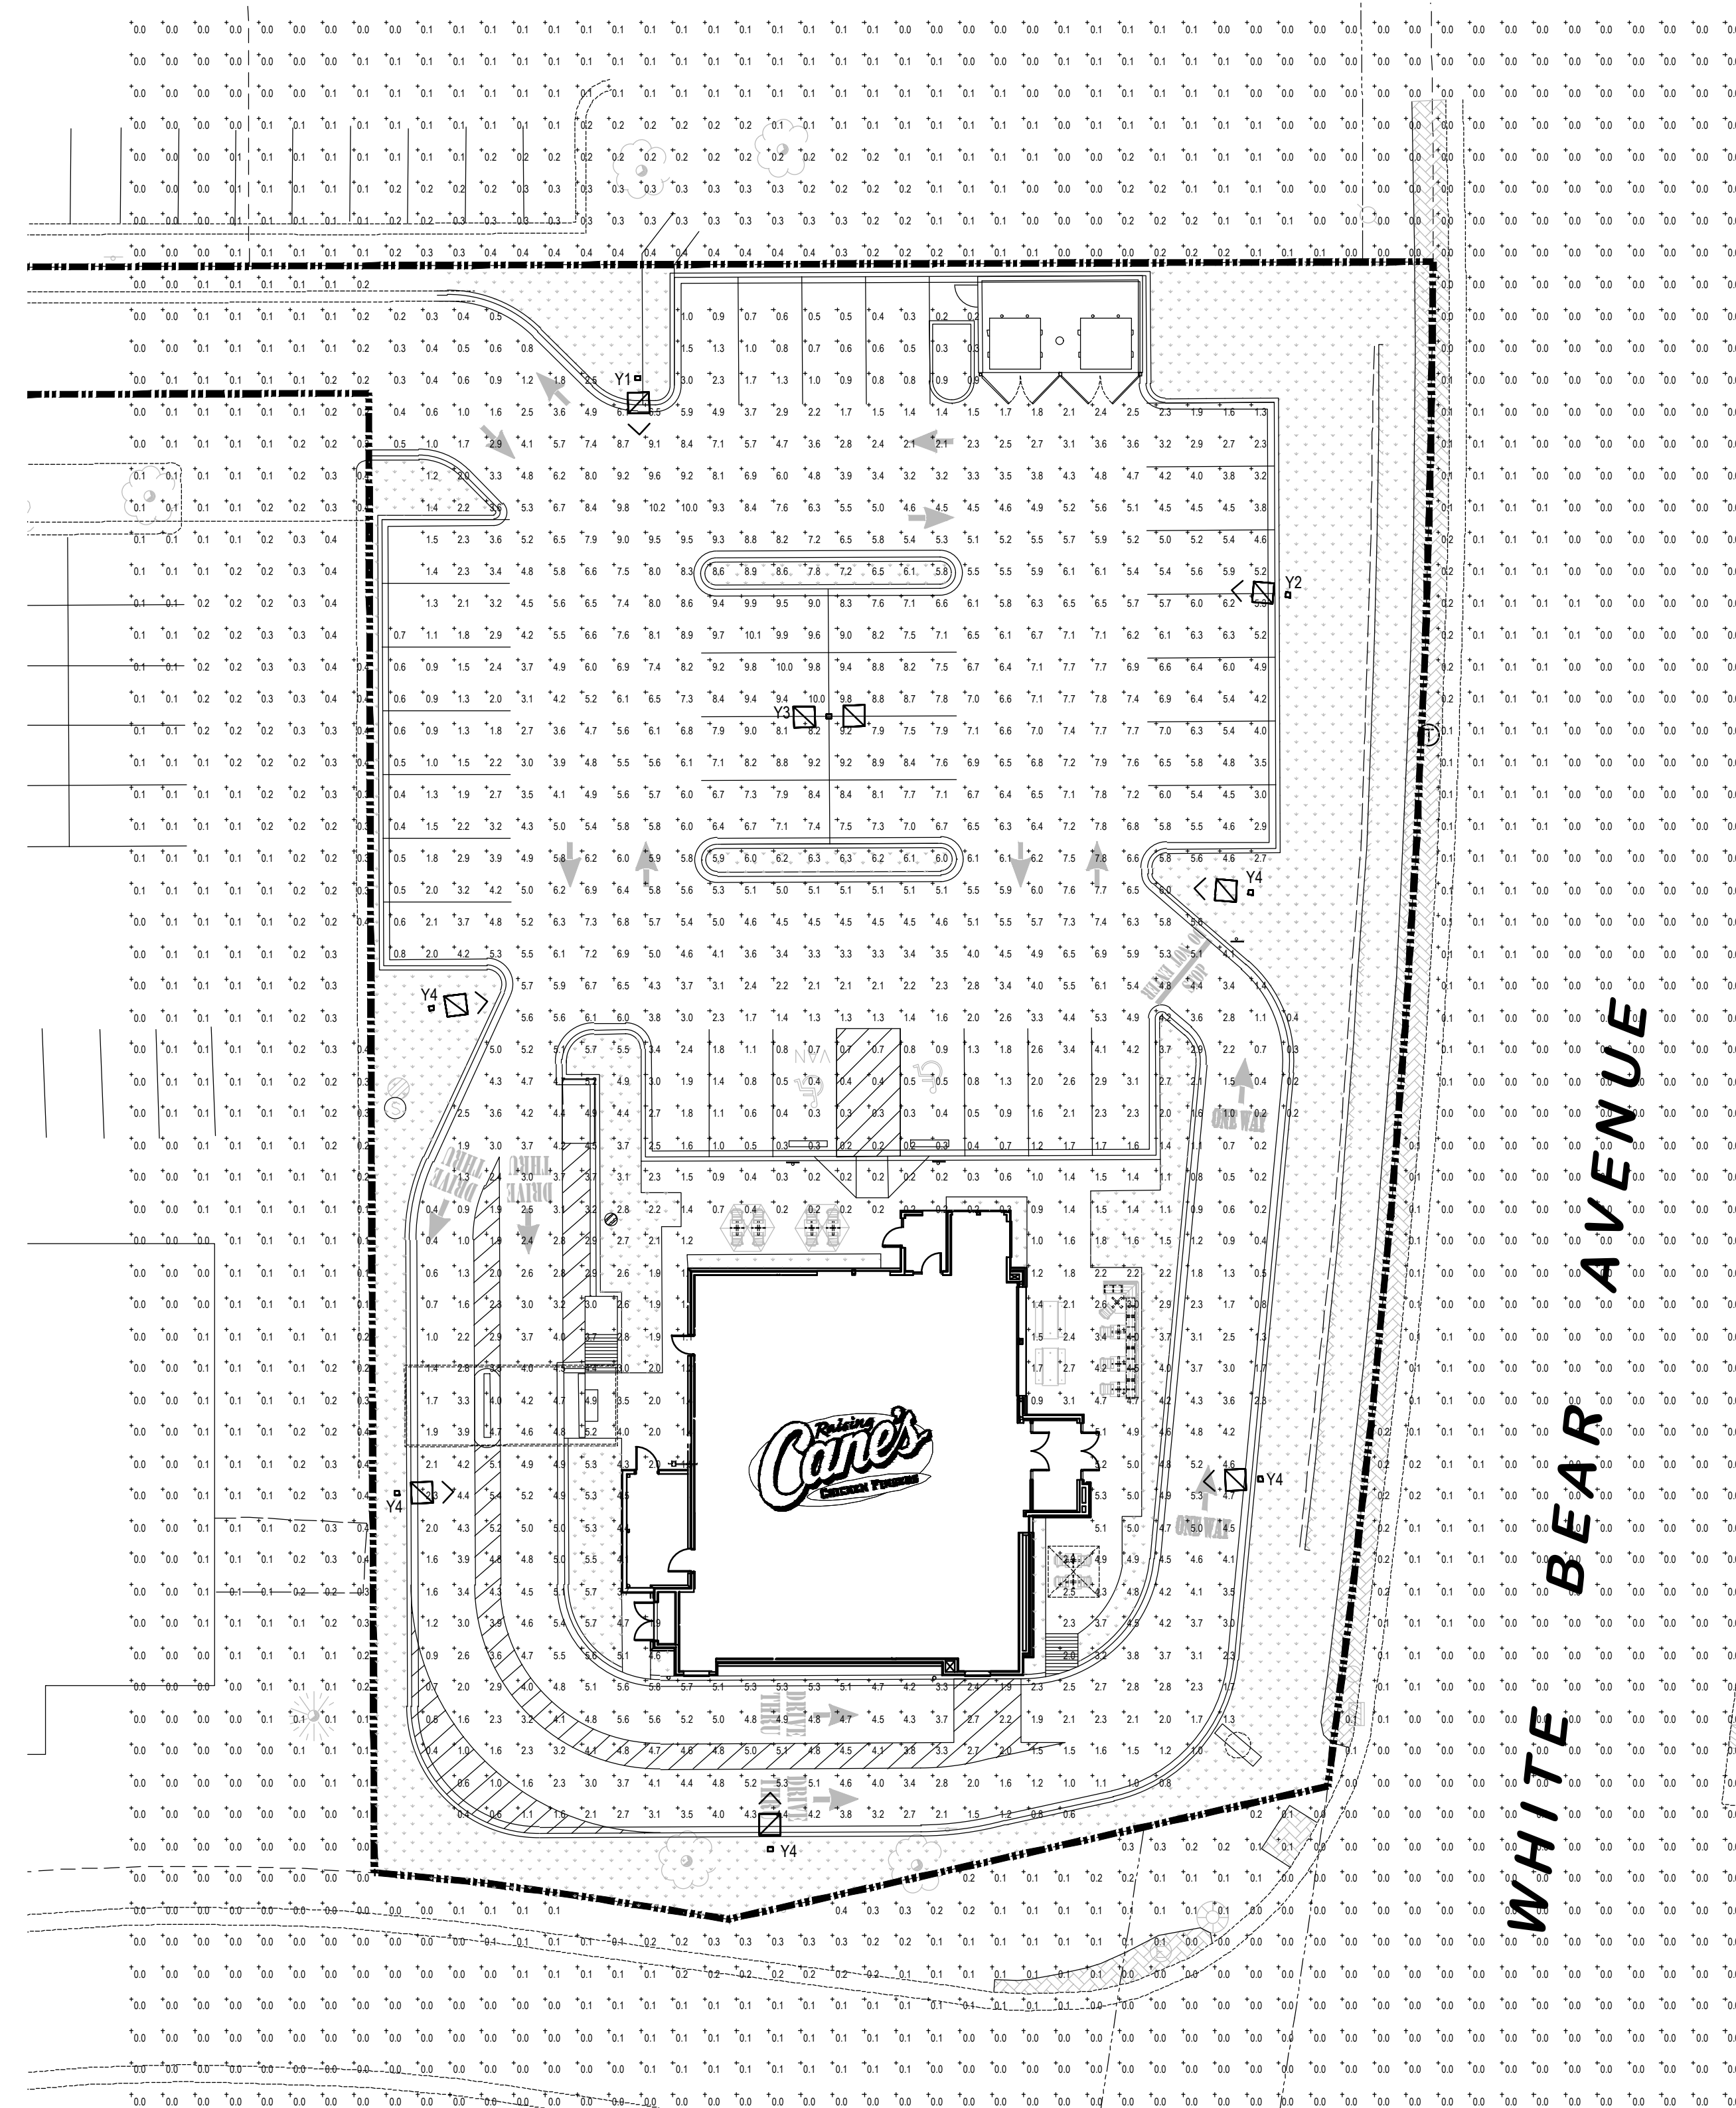

**PHOTOMETRIC SITE PLAN**  
 SCALE 1" = 20'-0"



Restaurant Support Office  
 6800 Bishop Road, Plano, TX 75024  
 Tele: 972-769-3100 Fax: 972-769-3101

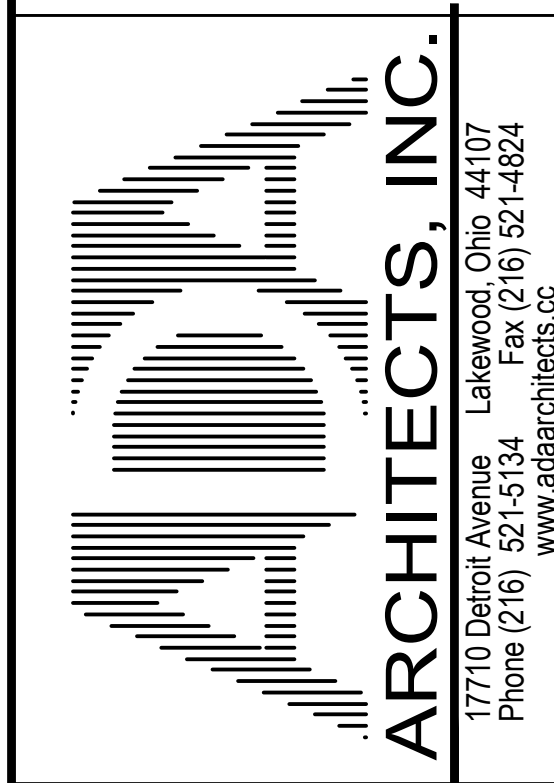

This document ("Instrument of Service") was prepared by ADA Architects, Inc. ("ADA") specifically for the referenced project and is not intended for any other use. ADA retains all common law, statutory and other reserved rights, including copyrights. This Instrument of Service shall not be used on other projects, for additions to this project or for completion of this project by others without ADA's prior written consent. Any unauthorized use of this Instrument of Service shall be at the User's sole risk and without liability to ADA. ADA makes no warranties, express or implied, of merchantability or of fitness for a particular purpose.

STORE:  
**RAISING CANE'S RESTAURANT**  
 MAPLEWOOD, MN

SHEET REVISIONS		
#	DATE	TYPE
1		
2		
3		
4		
5		
6		
7		
8		
9		
10		

**PHOTOMETRIC SITE PLAN**  
 DATE: 7.10.20  
 JOB NO. 20171  
**PH-1.0**  
 SHEET NO.